


Filename: Valveine Site Lighting - South Windsor.AGI

Luminaire Schedule							
Symbol	Qty	Label	Arrangement	Lum. Lumens	Lum. Watts	LLF	BUG Rating
—□—	2	SL4H	SINGLE	6945	70	0.900	B1-100-G2
□	4	SW4	SINGLE	3944	38.8	0.900	B1-100-G1
Description							
Lithonia DSX1 LED P2 40K TFTM MVOLT SPA HS DBBXD - SSS 20 4C DM19AS DBBXD 20FT POLE							
Lithonia DSXW1 LED 10C 1000 40K TFTM MVOLT DBBXD							
Calculation Summary							
Label	CalcType	Units	Avg	Max	Min	Avg/Min	Max/Min
SITE	Illuminance	Fc	0.86	5.1	0.0	N.A.	N.A.
DRIVEWAYS	Illuminance	Fc	1.81	5.1	0.1	18.10	51.00
PARKING	Illuminance	Fc	1.79	3.1	0.5	3.58	6.20

WOODS
PARCEL AREA
192828.1 SQ. FT.
4.43 ACRES

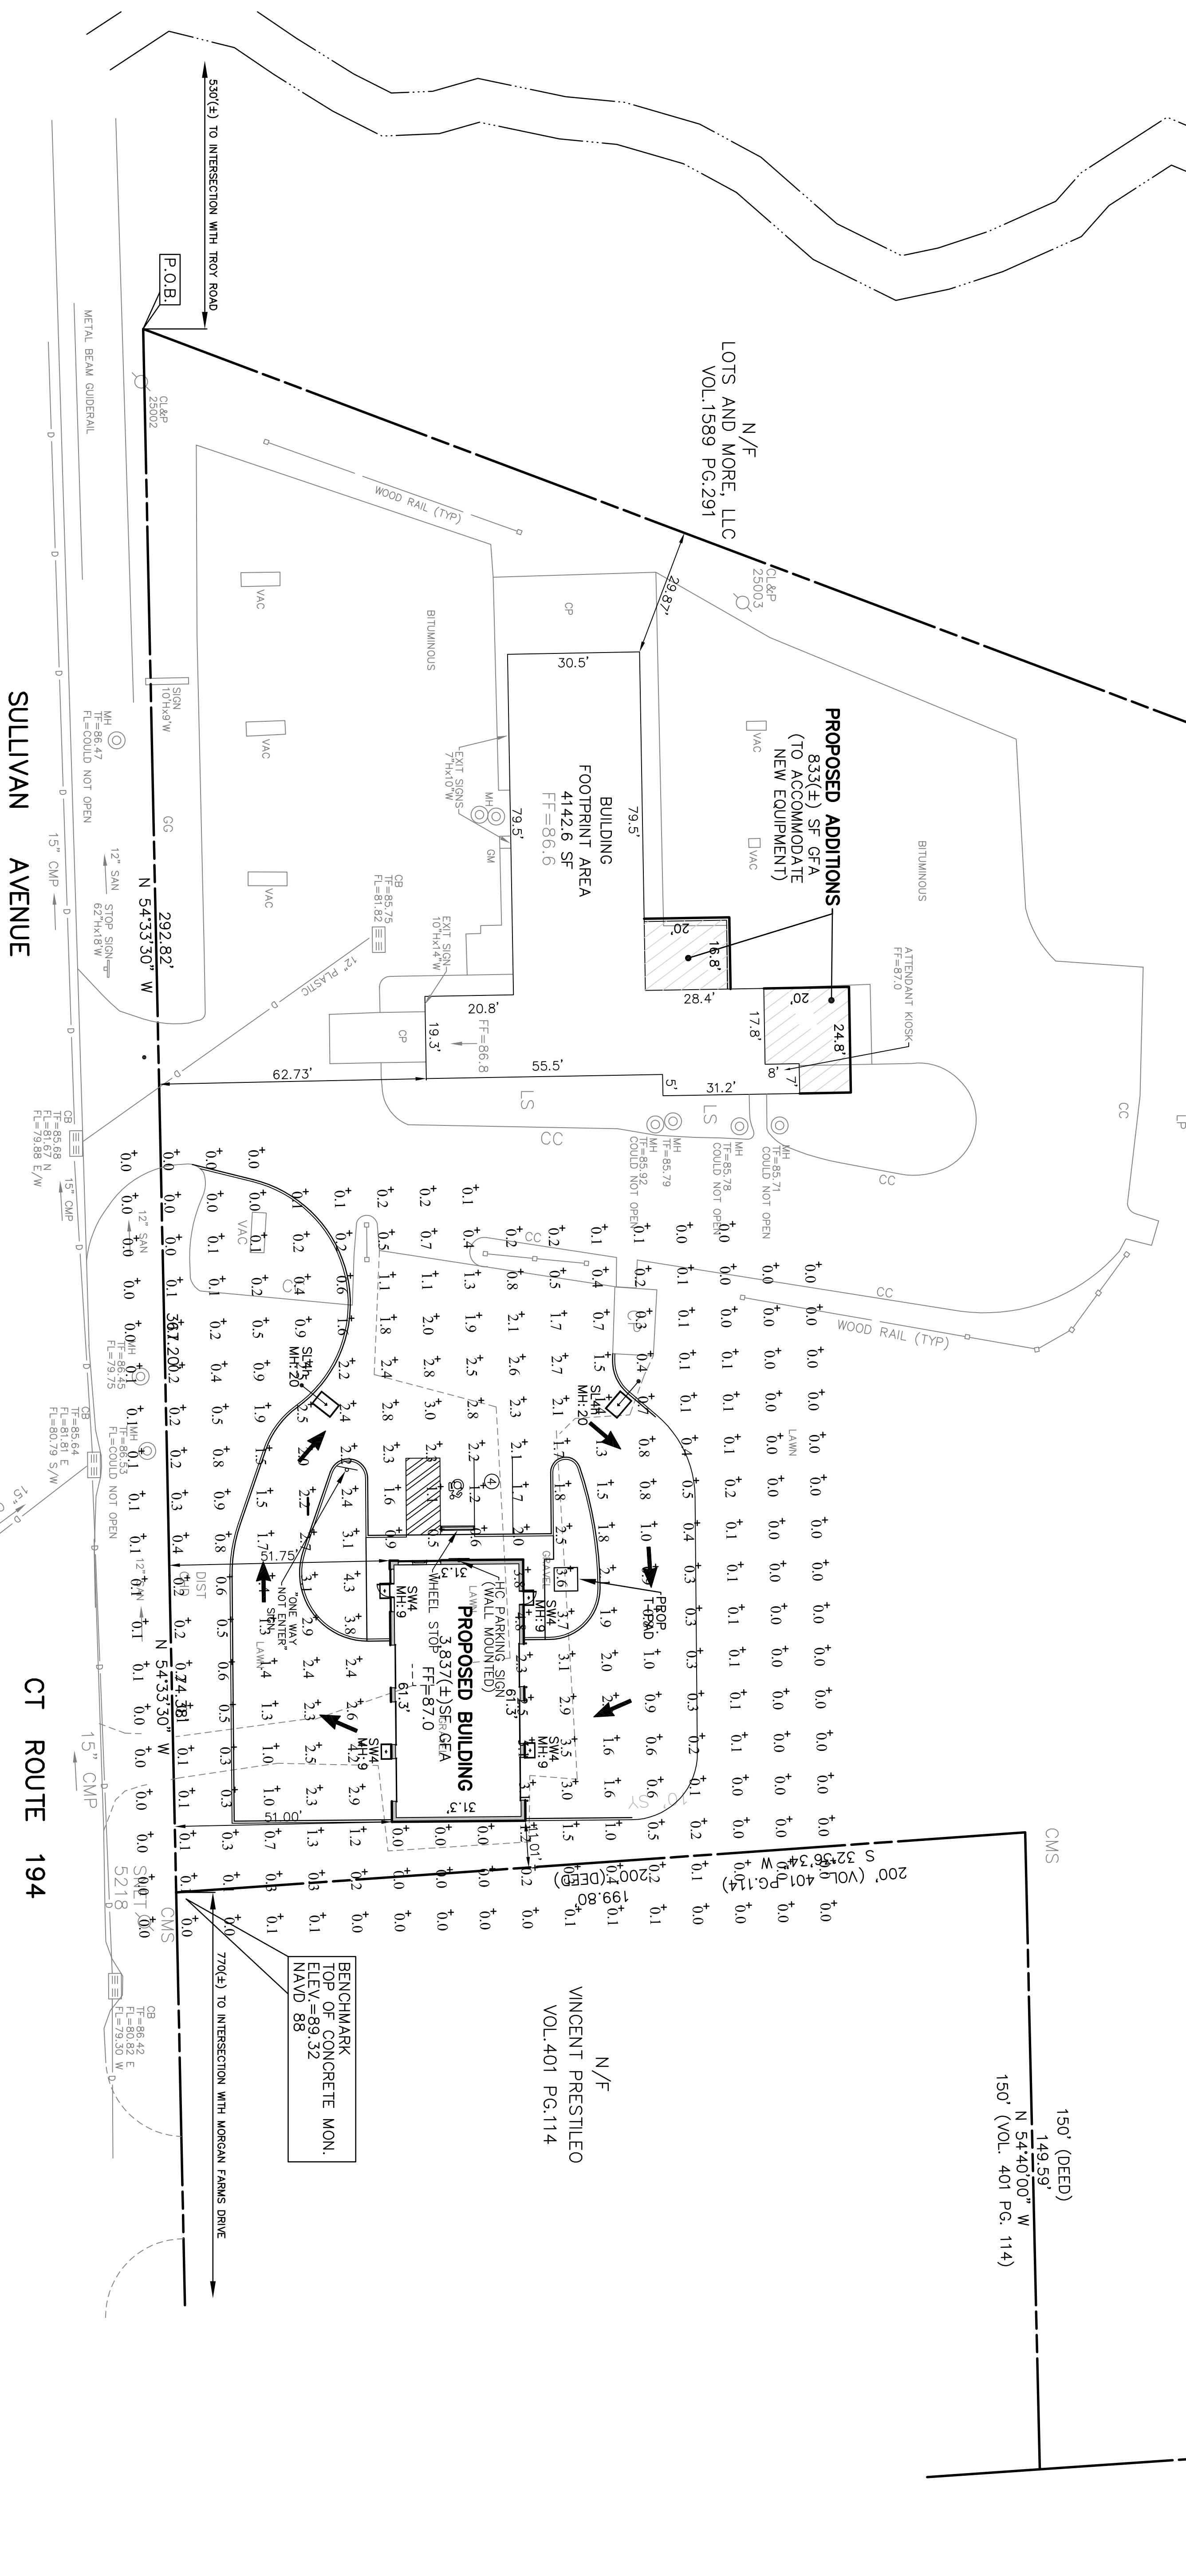

N/F
TOWN OF SOUTH WINDSOR
VOL.2015 PG.122

N/F
VINCENT PRESTILEO
VOL.401 PG.114

N/F
SOMERLARK PROPERTIES LLC
VOL.2311 PG.117

PHOTOMETRIC PLAN

SCALE: 1"=20'
SOMERLARK PROPERTIES LLC
VOL.2311 PG.117

PROJECT
Valvoline
818 SULLIVAN AVENUE, SOUTH WINDSOR, CT

DRAWN BY
G.R.W.
DATE
09-08-20
2155 EAST MAIN STREET TORRINGTON, CT 06790
860-482-7613/WEB: www.borghesibuilding.com

APPROVED BY
A.R.B.
SCALE
AS NOTED

REVISIONS
09-18-20 REV. PROP. ADDITION TO EXIST. CAR WASH
09/21/20- REVISED LAYOUT & SIZE OF NEW ADDITIONS TO CAR WASH

SEAL