


LUMINAIRE SCHEDULE

Symbol	Label	Qty	Catalog Number	Description	Lamp	File	Lumens	LLF	Watts
	WL	2	GARDCO GWM-A09-830-T4M-JUVV FINISH MOUNTED AT 16 FEET	Gardco GeoForm wedge medium LED wall sconce, 40 LED's, 3000K CCT, TYPE T4M OPTIC, 80CRI	(2) LDGN66 Reduced Pixelated Array(s) DRIVEN AT 1160mA	GWM-A09-830-T4M.lvs	Absolute	0.85	38.7
	WS	2	GARDCO GWS-A01-830-T4M-JUVV FINISH MOUNTED AT 8 FEET	Geoform Wall Sconce - Wedge, 20 LED's, 3000K CCT, TYPE T4M OPTIC, 80CRI	(1) LDGN66 Reduced Pixelated Array(s) DRIVEN AT 317mA	GWS-A01-830-T4M.lvs	Absolute	0.85	10.2
	PL	3	GARDCO OPF-S-A01-730-BLC SRS CB 4 11 16 DTX FINISH	OptiForm - Small, 40 LED's, 3000K CCT, TYPE BLC OPTIC, 70CRI MOUNTED AT 16 FEET	(1) LDGN66 Array(s) DRIVEN AT 650mA	OPF-S-A01-730-BLC.lvs	Absolute	0.85	41.88


STATISTICS

Description	Symbol	Avg	Max	Min	Max/Min	Avg/Min
PARKING LOT	+	1.4 fc	5.1 fc	0.1 fc	51.0:1	14.0:1

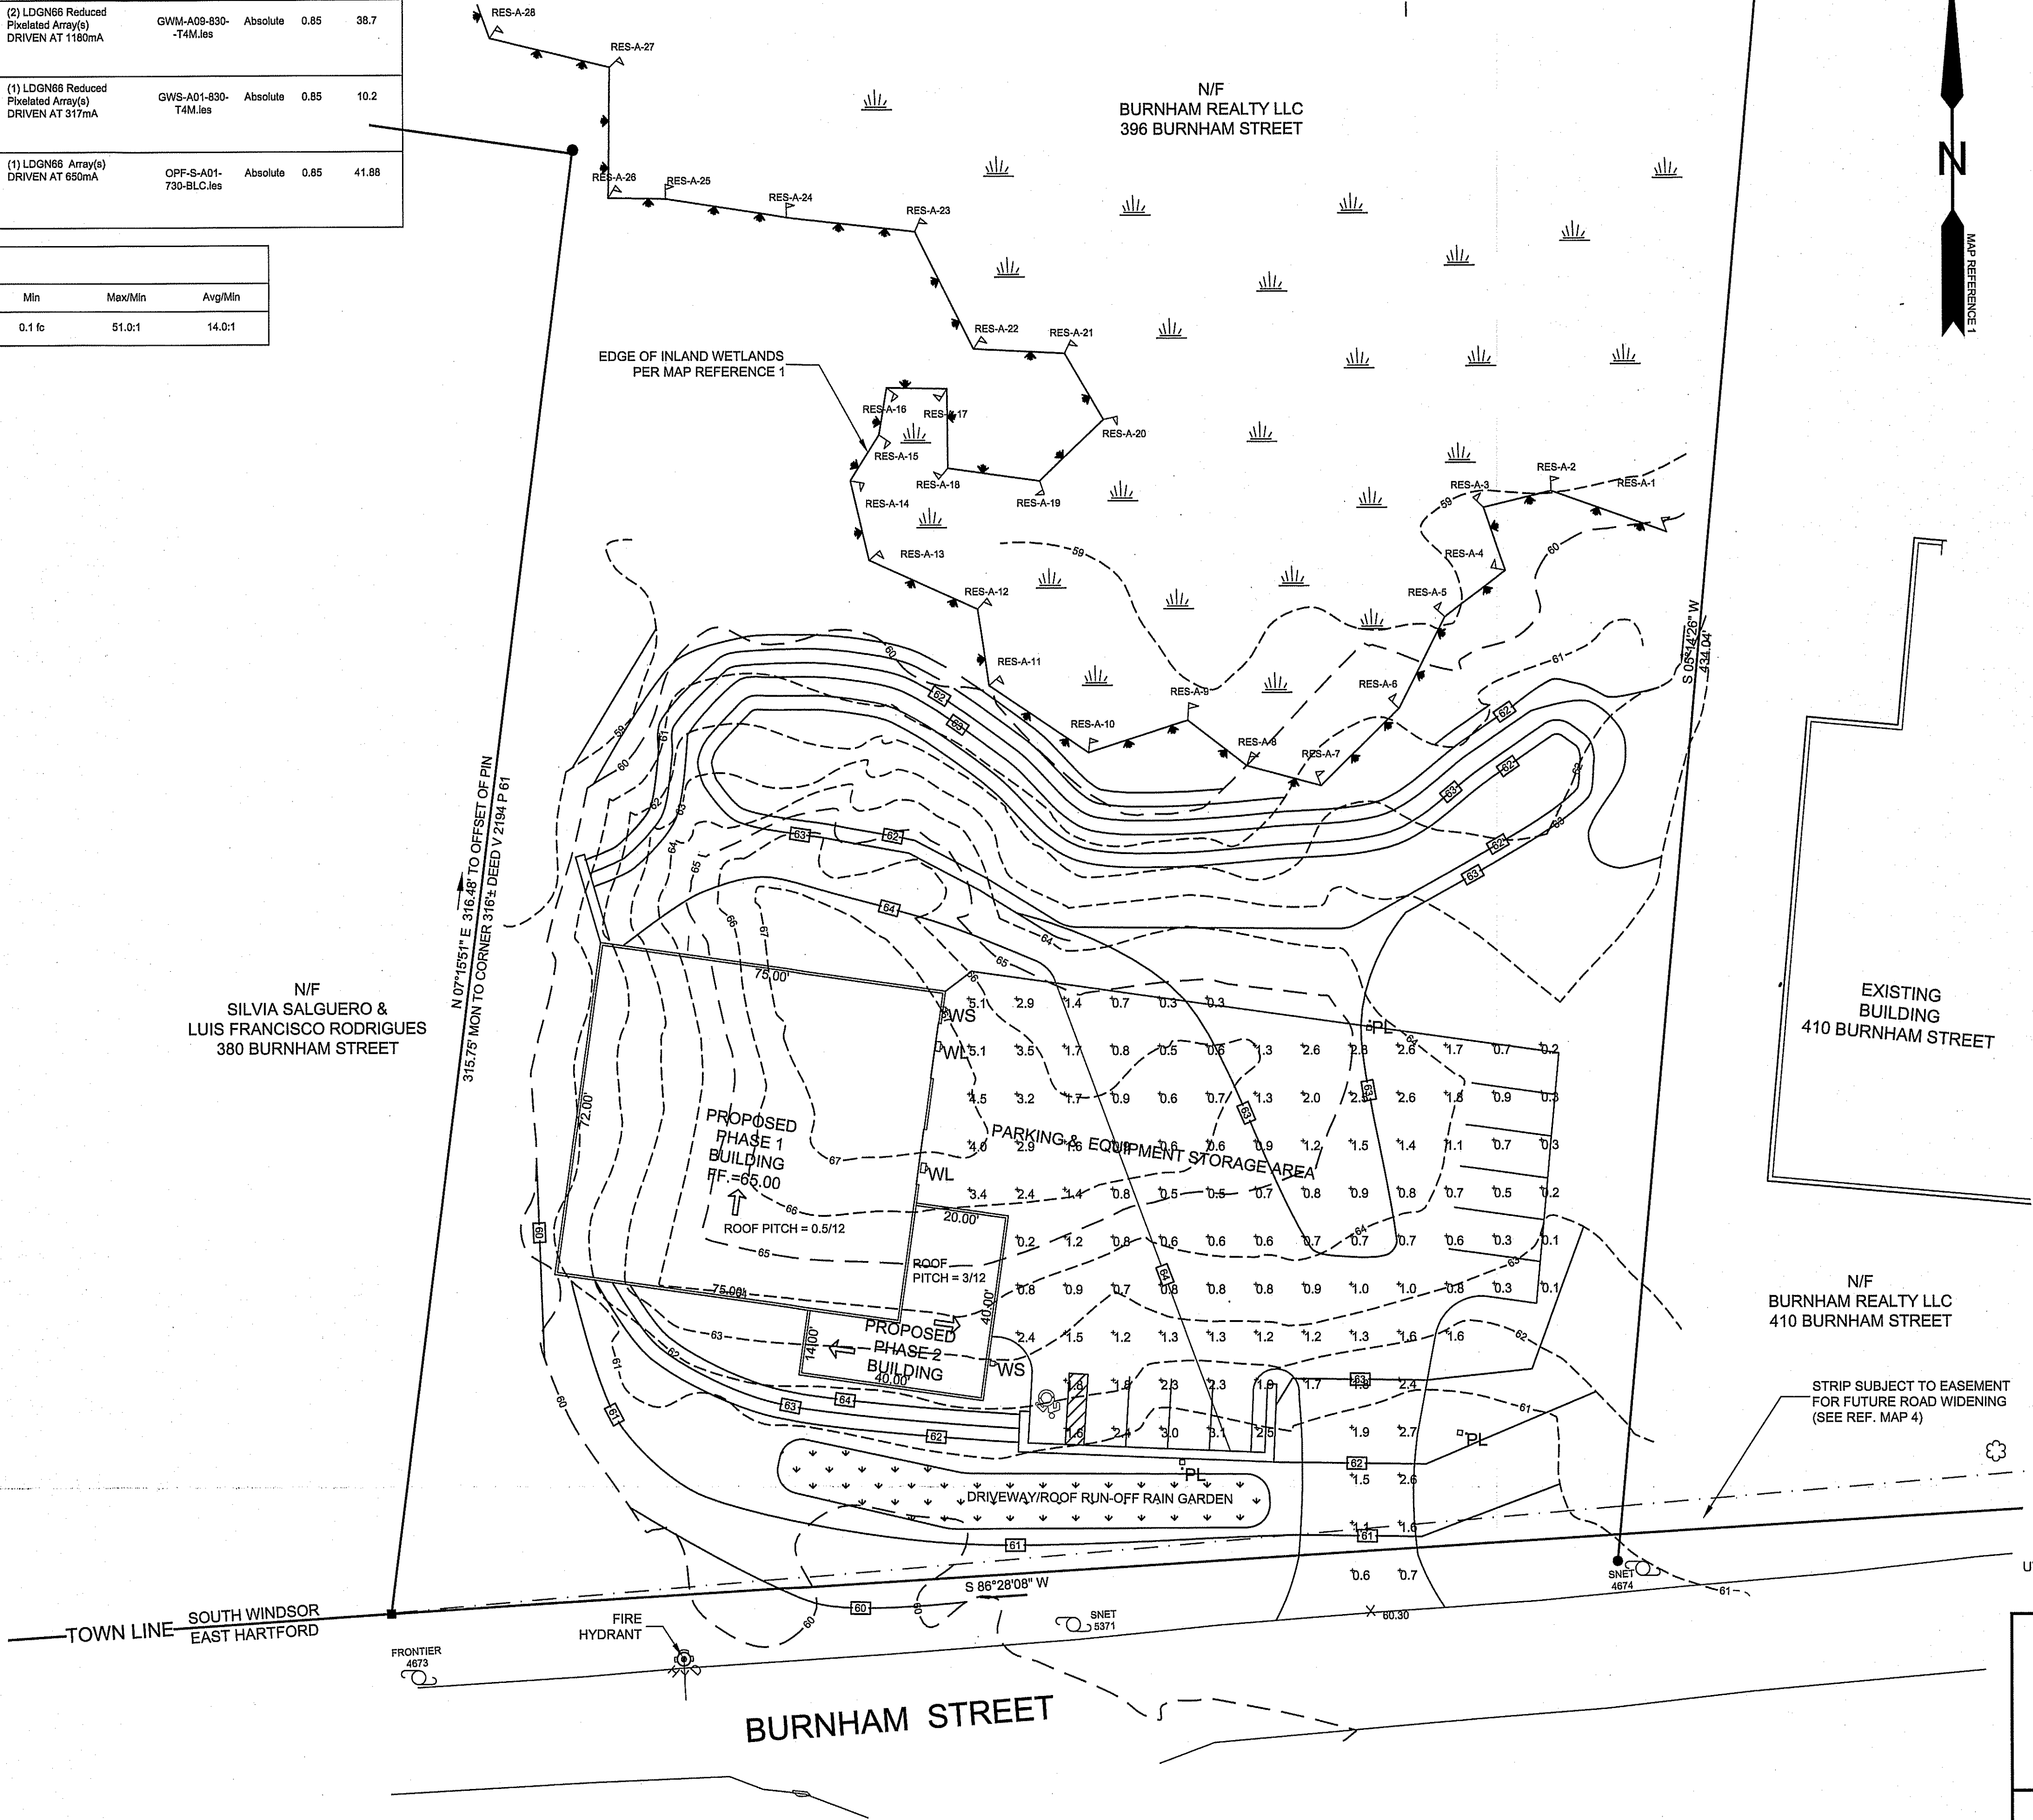

LEGEND

- EXISTING IRON ROD
- EXISTING UTILITY POLE
- EXISTING SPOT GRADE
- EXISTING CONTOUR
- PROPOSED CONTOUR
- TREE

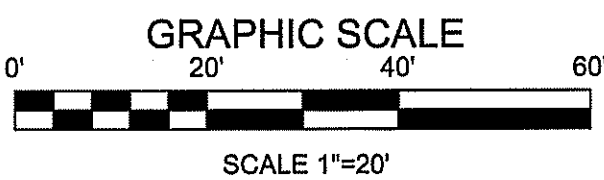

TO MY KNOWLEDGE AND BELIEF, THIS MAP IS SUBSTANTIALLY CORRECT AS NOTED HEREON.

ANDREW F. BUSHNELL P.E. L.S. 24591
THIS MAP IS NOT VALID UNLESS IT BEARS THE EMBOSSED SEAL OF THE LICENSED
LAND SURVEYOR WHOSE REGISTRATION NUMBER AND SIGNATURE APPEAR ABOVE.

PLAN PREPARED FOR

BURNHAM REALTY, LLC

396 BURNHAM STREET SOUTH WINDSOR, CT.

LIGHTING PLAN

SCALE: 1"=20' DATE: 1/23/2023 FILE NO. 2021-134 SHEET: 1 OF 1

BUSHNELL ASSOCIATES LLC.

CIVIL ENGINEERING AND LAND SURVEYING

563 WOODBRIDGE STREET MANCHESTER, CT. 06042

860-643-7875

REVISIONS: